


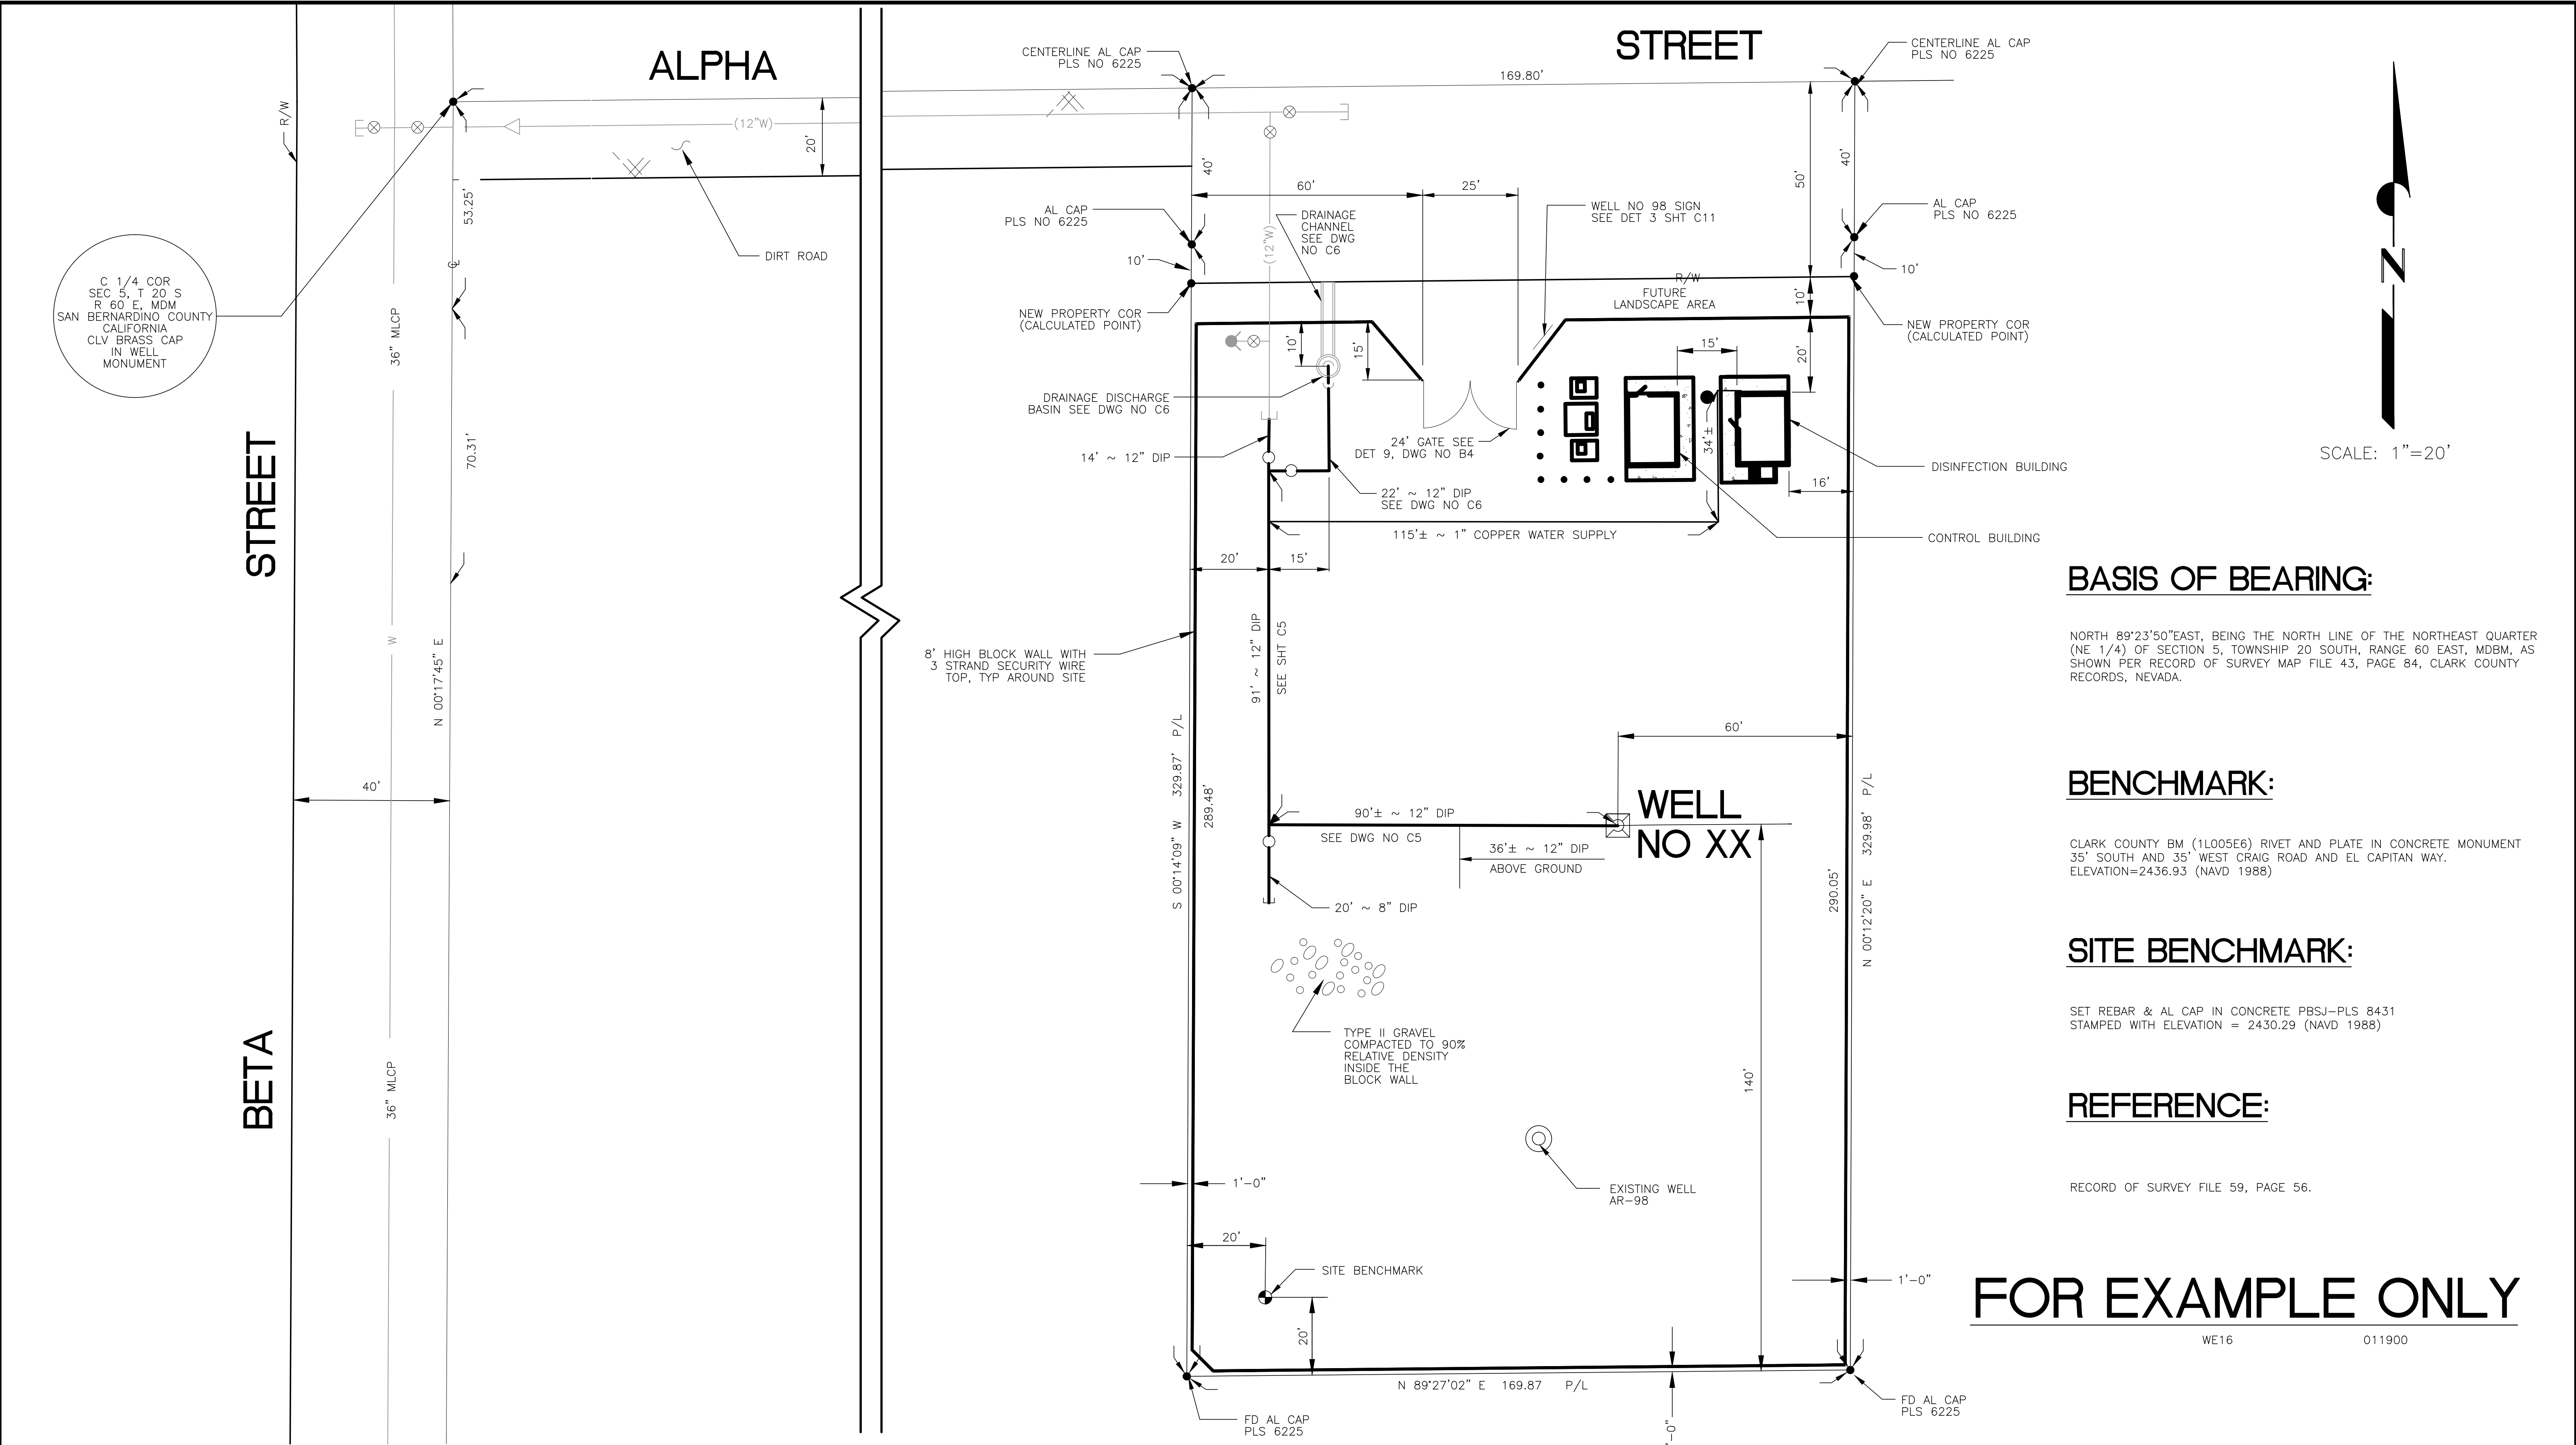

UNDERGROUND SERVICE ALERT
CALL: TOLL FREE
811
TWO WORKING DAYS
BEFORE YOU DIG

ENGINEER'S SEAL	APPROVED BY: _____ REGISTERED CIVIL ENGINEER No. XXXXX	DATE: _____	DESIGNED BY: XX_	DRAWN BY: XX_	CHECKED BY: XX_	DESIGN ENGINEER	SBMWD ENGINEER	BENCHMARK: _____ _____ _____ ELEV.= XXXX.XX FT.	CITY OF SAN BERNARDINO MUNICIPAL WATER DEPARTMENT	DRAWING SCALES: HORIZ: N/A VERT: N/A
									WELL NO. XXXX	C.O. NO.: XXXX
									SITE PLAN	DWG C1
									SHEET 5 OF XX	

C-XXXX-5-C-C1.DWG